


201 FLOOR PLAN LEVEL TWO
SCALE: 1/8" = 1'-0"

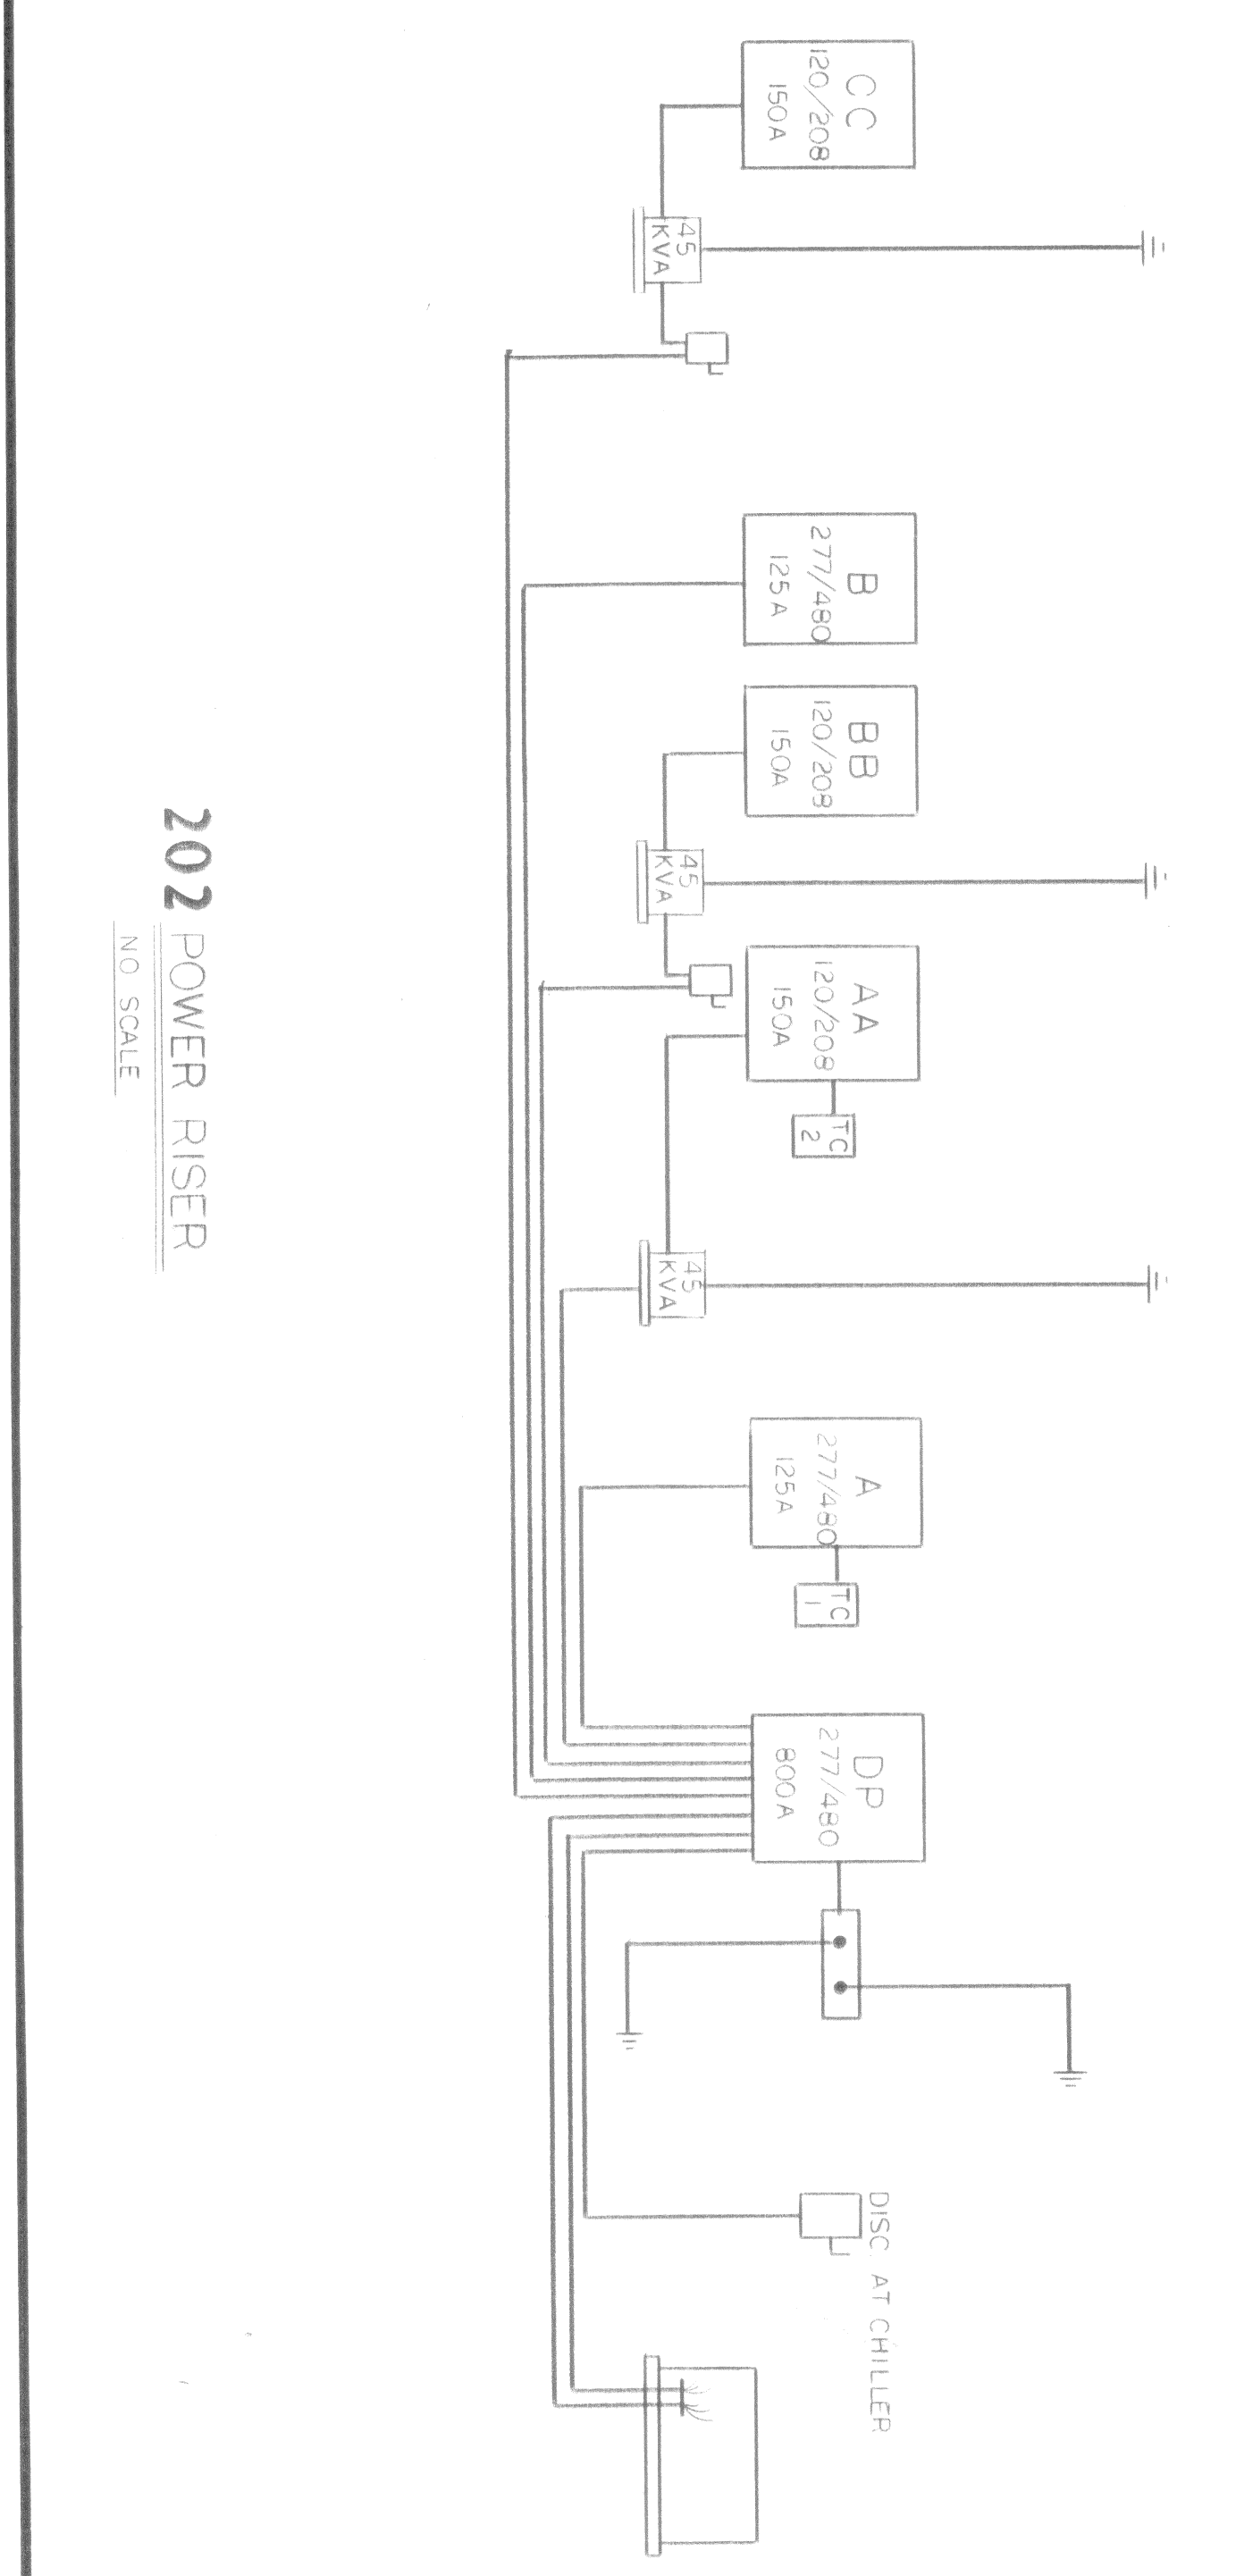

202 POWER RISER
NO SCALE